


OIL INTERCEPTOR  
TO BE SELECTED PER  
SEA COAST STANDARDS.

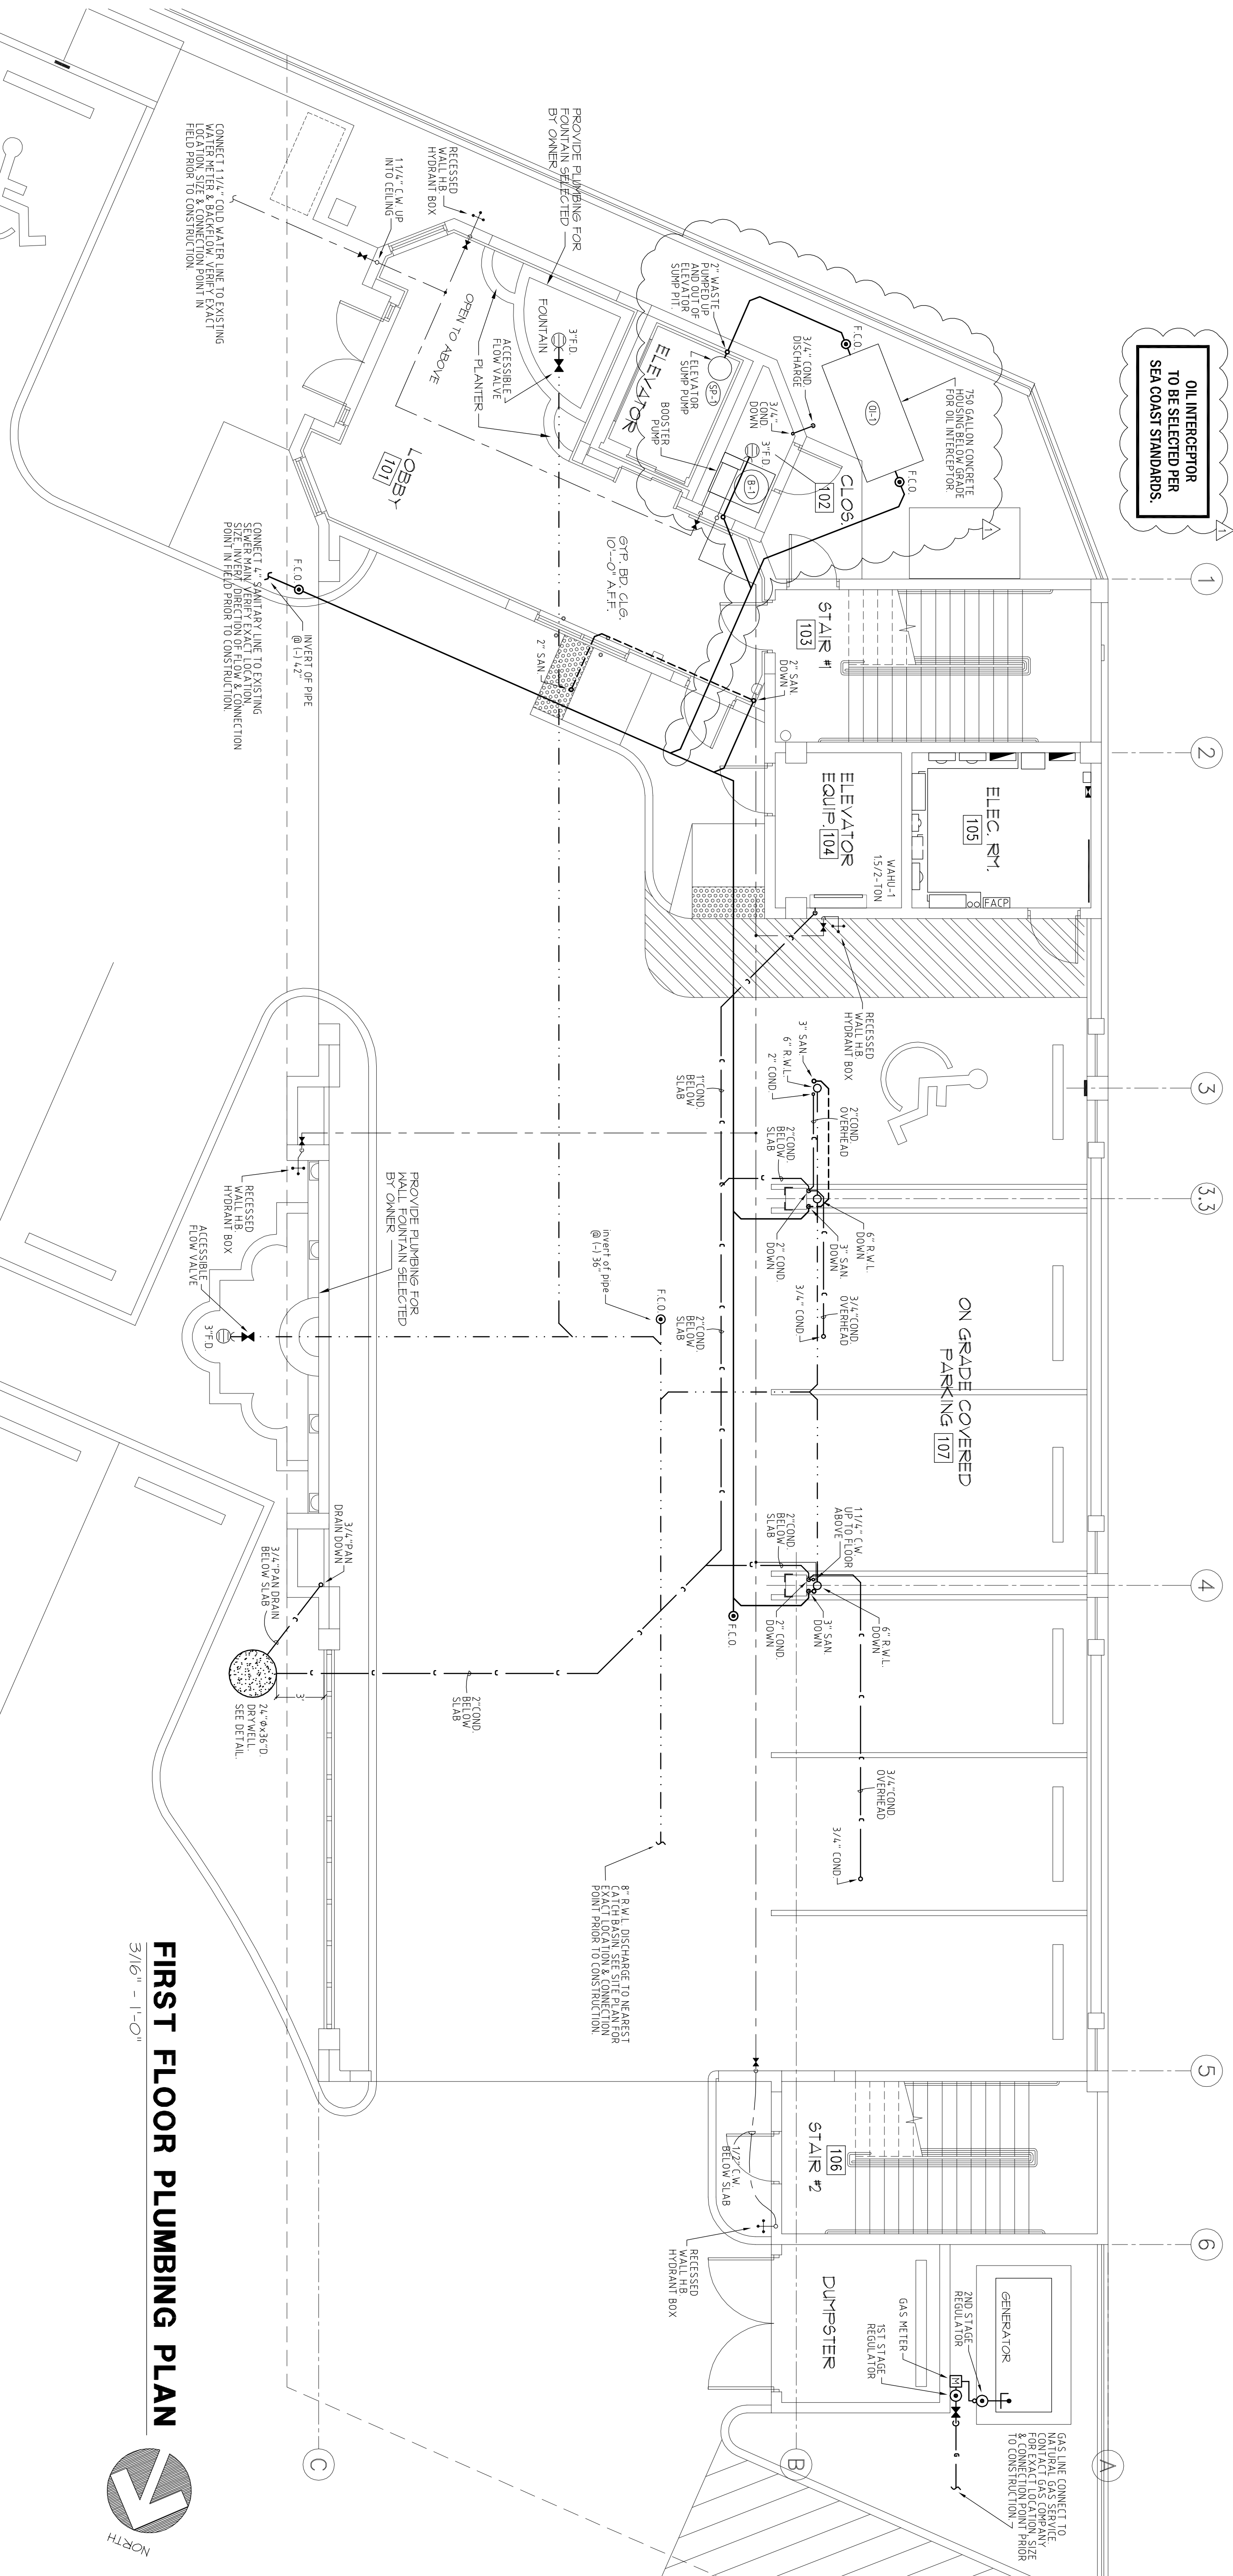


**FIRST FLOOR PLUMBING PLAN**  
3/16" = 1'-0"



TOTAL GAS CONSUMPTION

ITEM	BTUH
GENERATOR	758150

NOTES:  
 1. INSTALLATION OF ALL GAS PIPING SHALL BE PER IBC GAS PIPING STANDARD.  
 2. REFER TO MASTER FOR PIPE MATERIALS.  
 3. PRESSURE TEST GAS PIPING FOR LEAKS PRIOR TO CONNECTING GAS SUPPLY.  
 4. CHECK ALL 8 TO 1 WITH HAND ACTUATORS.  
 5. VERIFY LOCATION OF EQUIPMENT PRIOR TO INSTALLATION.  
 6. ALL CONDENSATE EXHAUST GAS PIPE BELOW ABOVE GRADE AND SHALL BE INSTALLED 30 INCHES ABOVE THE FINISH FLOOR OF WATER.

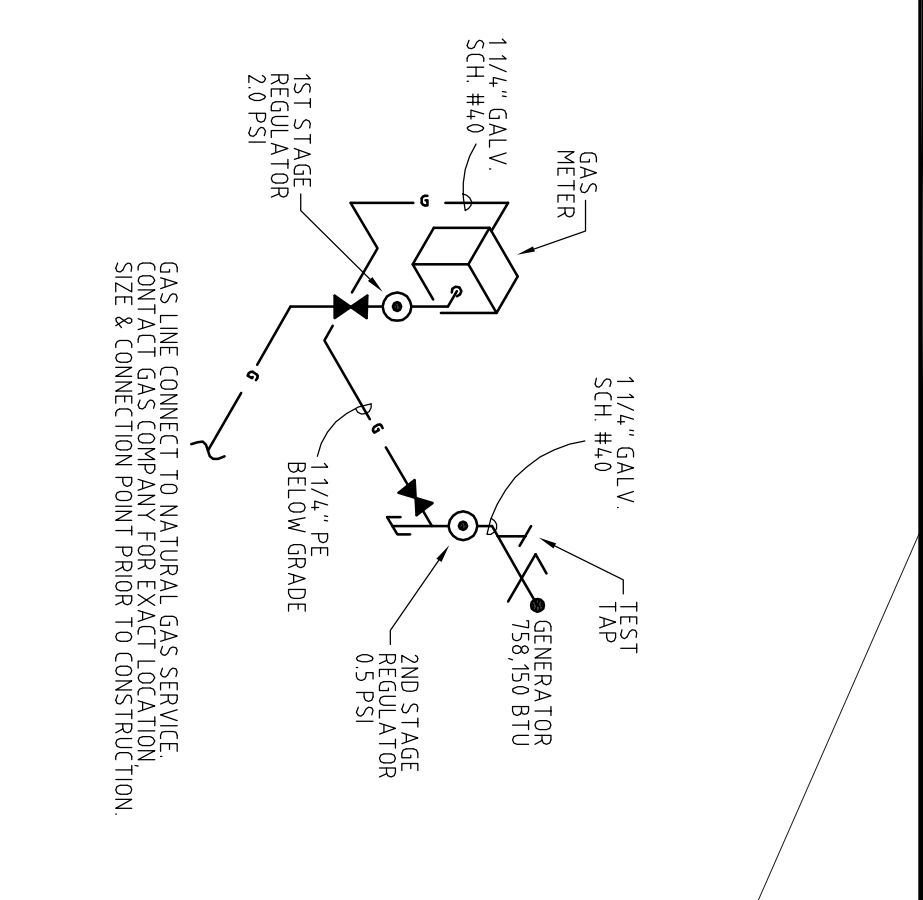

**PLUMBING LEGEND**

	COLD WATER LINE
	HOT WATER LINE
	SANITARY LINE
	CONDENSATE LINE
	RAIN WATER LEADER
	FLOOR DRAIN
	SHUT-OFF VALVE
	HOSE BIBB WITH SOV & VACUUM BREAKER

**RISER NO. 1**

**GAS**

NOT TO SCALE

COPYRIGHTED 2010  
 THIS ARCHITECTURAL DRAWING IS GIVEN IN CONFIDENCE. NO USE OR DISSEMINATION MAY BE MADE WITHOUT PRIOR WRITTEN CONSENT OF THE ARCHITECT. ALL COMMON LAW RIGHTS OF COPYRIGHT AND OTHERWISE ARE HEREBY SPECIFICALLY RESERVED.

NO CHANGES SHALL BE MADE TO THESE PLANS WITHOUT PRIOR APPROVAL FROM THE ENGINEER OF RECORD. ALL CHANGES SHALL BE SUBMITTED FOR REVIEW PRIOR TO INSTALLATION.  
 NOT FOR BID UNTIL PERMIT HAS BEEN ISSUED.

PERMIT SET: 01/20/11

**FREE CONSULTING**

1.520 N.W. 82ND STREET, SUITE 100  
 BOCA RATON, FL 33492  
 TEL: (561) 391-9292 FAX: (561) 391-1989  
 ENGINEER OF AUTHORIZATION NO. 381107  
 MARTIN WHITLOCK, P.E. LICENSE #53899  
 EMAIL: INFO@FREECONSULTING.COM

**PECK PLAZA**  
 1295 U.S. HIGHWAY ONE  
 NORTH PALM BEACH, FLORIDA

**DRAWN** C/AB/AN  
**CHECKED** MW  
**DATE** 01/20/11  
**SCALE** AS NOTED  
**JOB NO.** 10193  
**SHEET**

**P1.01**

OF 6 SHEETS

REVISIONS	BY
1. 03/09/11 SEACOST UTILITY COMMENTS	AB